



163807

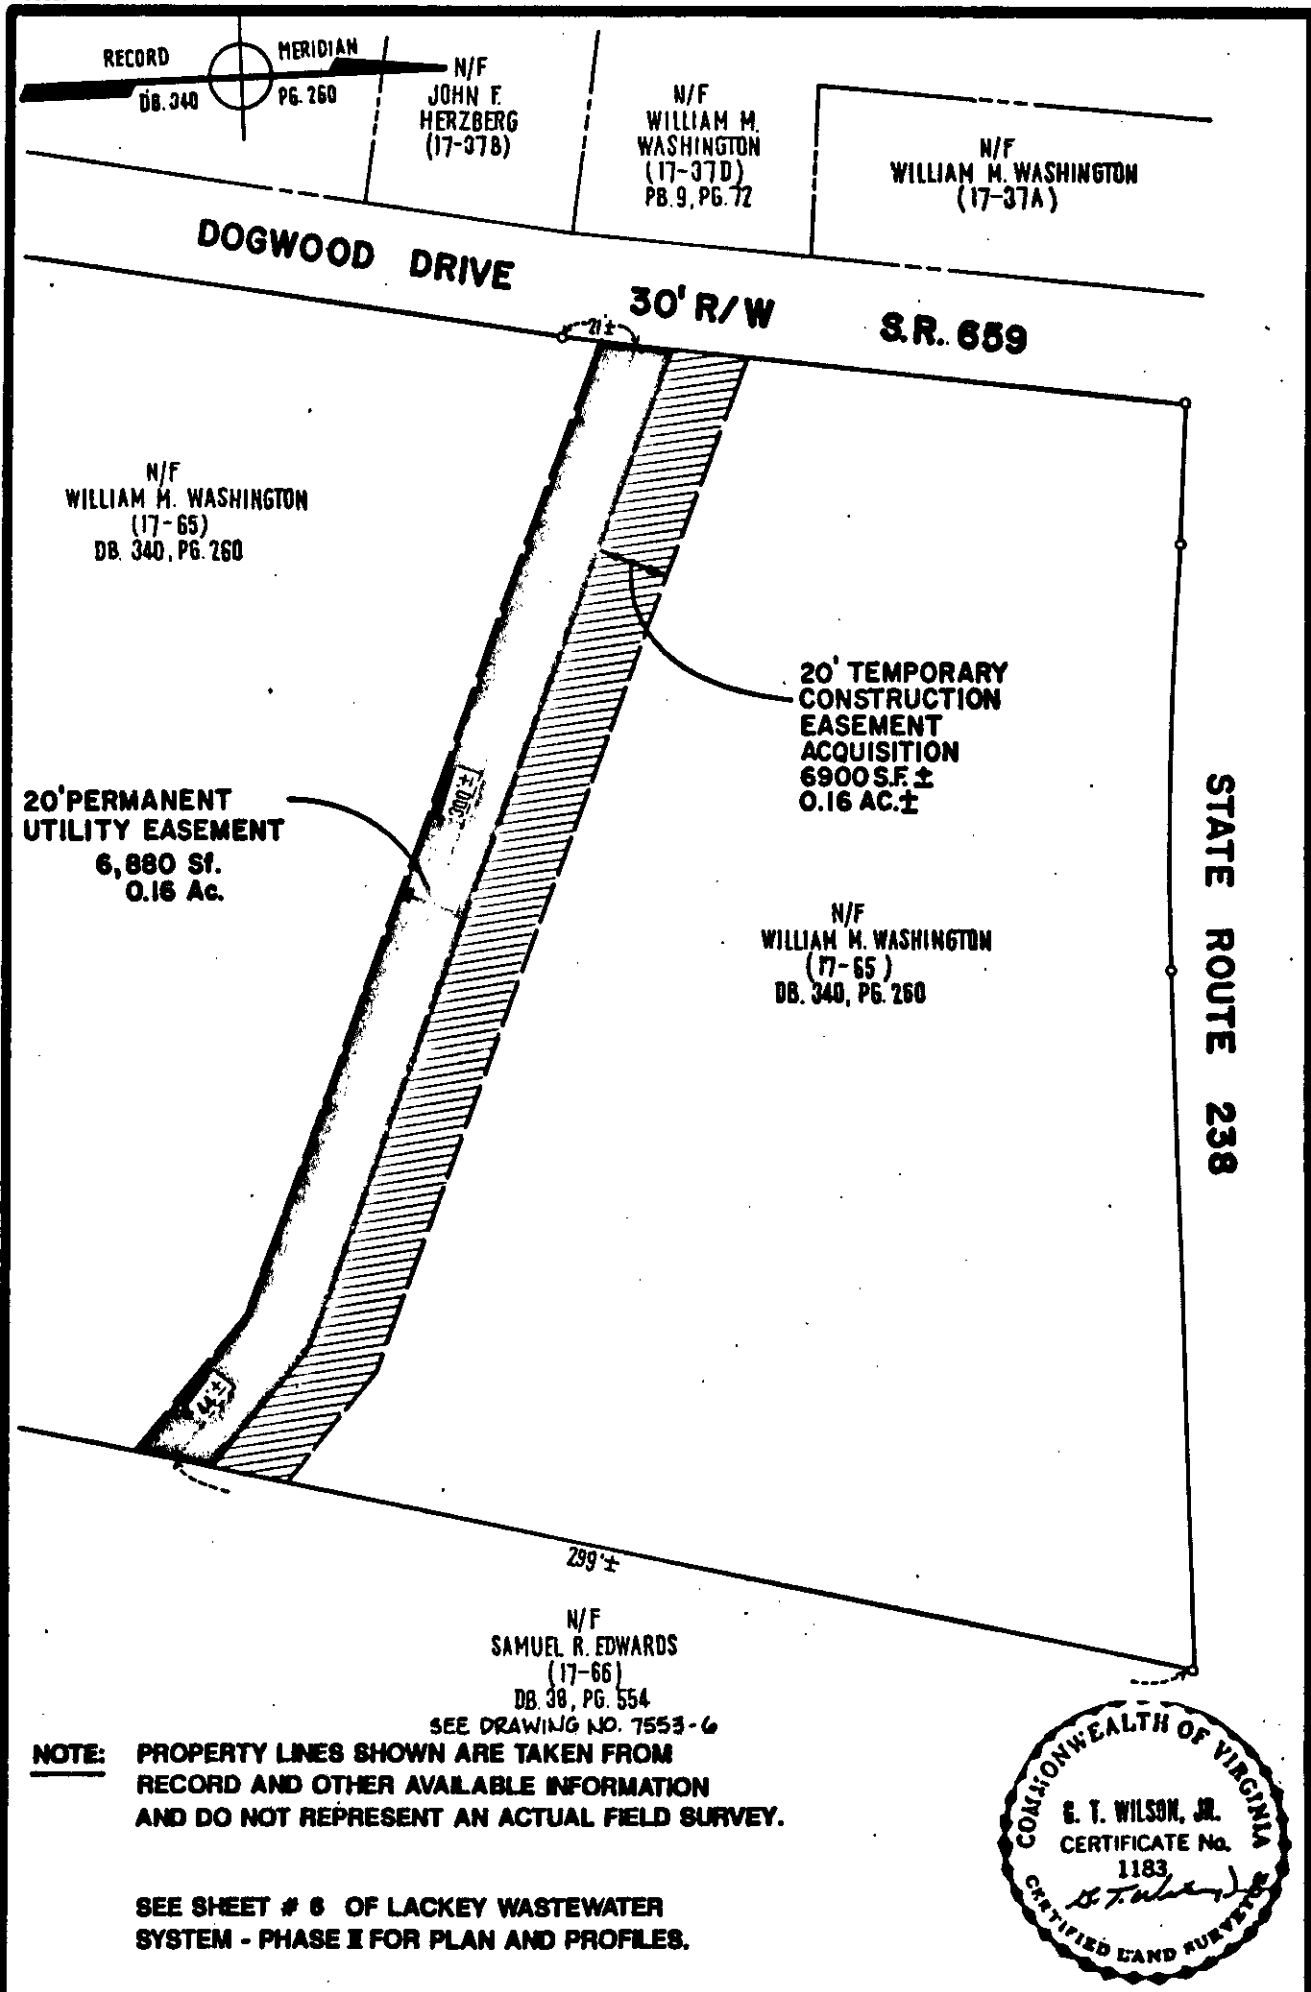

NOTE: PROPERTY LINES SHOWN ARE TAKEN FROM RECORD AND OTHER AVAILABLE INFORMATION AND DO NOT REPRESENT AN ACTUAL FIELD SURVEY.

SEE SHEET # 6 OF LACKEY WASTEWATER SYSTEM - PHASE II FOR PLAN AND PROFILES.

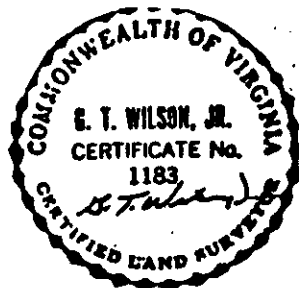

Consulting Engineers

Engineers, Surveyors, Planners

Williamsburg, Virginia

**PLAT SHOWING 20 FT. EASEMENT
THROUGH THE LANDS OF WILLIAM M. WASHINGTON
TO: THE COUNTY OF YORK**

NELSON DISTRICT

YORK COUNTY

VIRGINIA

Scale: 1" = 50'

Ref.: NOTED

Date: 7/2/1991

Job No.: 7553-7